


LIGHTING LEGEND

SYMBOL	DESCRIPTION	QTY	SYMBOL	DESCRIPTION	QTY	SYMBOL	DESCRIPTION
	selected 6" recessed ceiling mounted PLC downlight (square)	13		selected designer pendent light	6		existing aircon provided by developer
	selected 3" recessed LED eye ball	11		selected 4ft 3 fin designer fan	4		switch point location
	selected 1200mm (L) LED T5 light tube (WARM WHITE)	44		selected 3ft 3 fin designer baby fan	2		2 way switch point location
	selected 900mm (L) LED T5 light tube (WARM WHITE)	8		new emergency light (down light type)	2		sensor light ( cabinet door / movement )
	selected 300mm (L) LED T5 light tube (WARM WHITE)	10		selected wall light	1		
	selected LED strip ( 5m x3units , 10m x10units )	13		new 300x300mm exhaust fan	3		

\* transformer 10m x 9 units , 5 m x 11 units

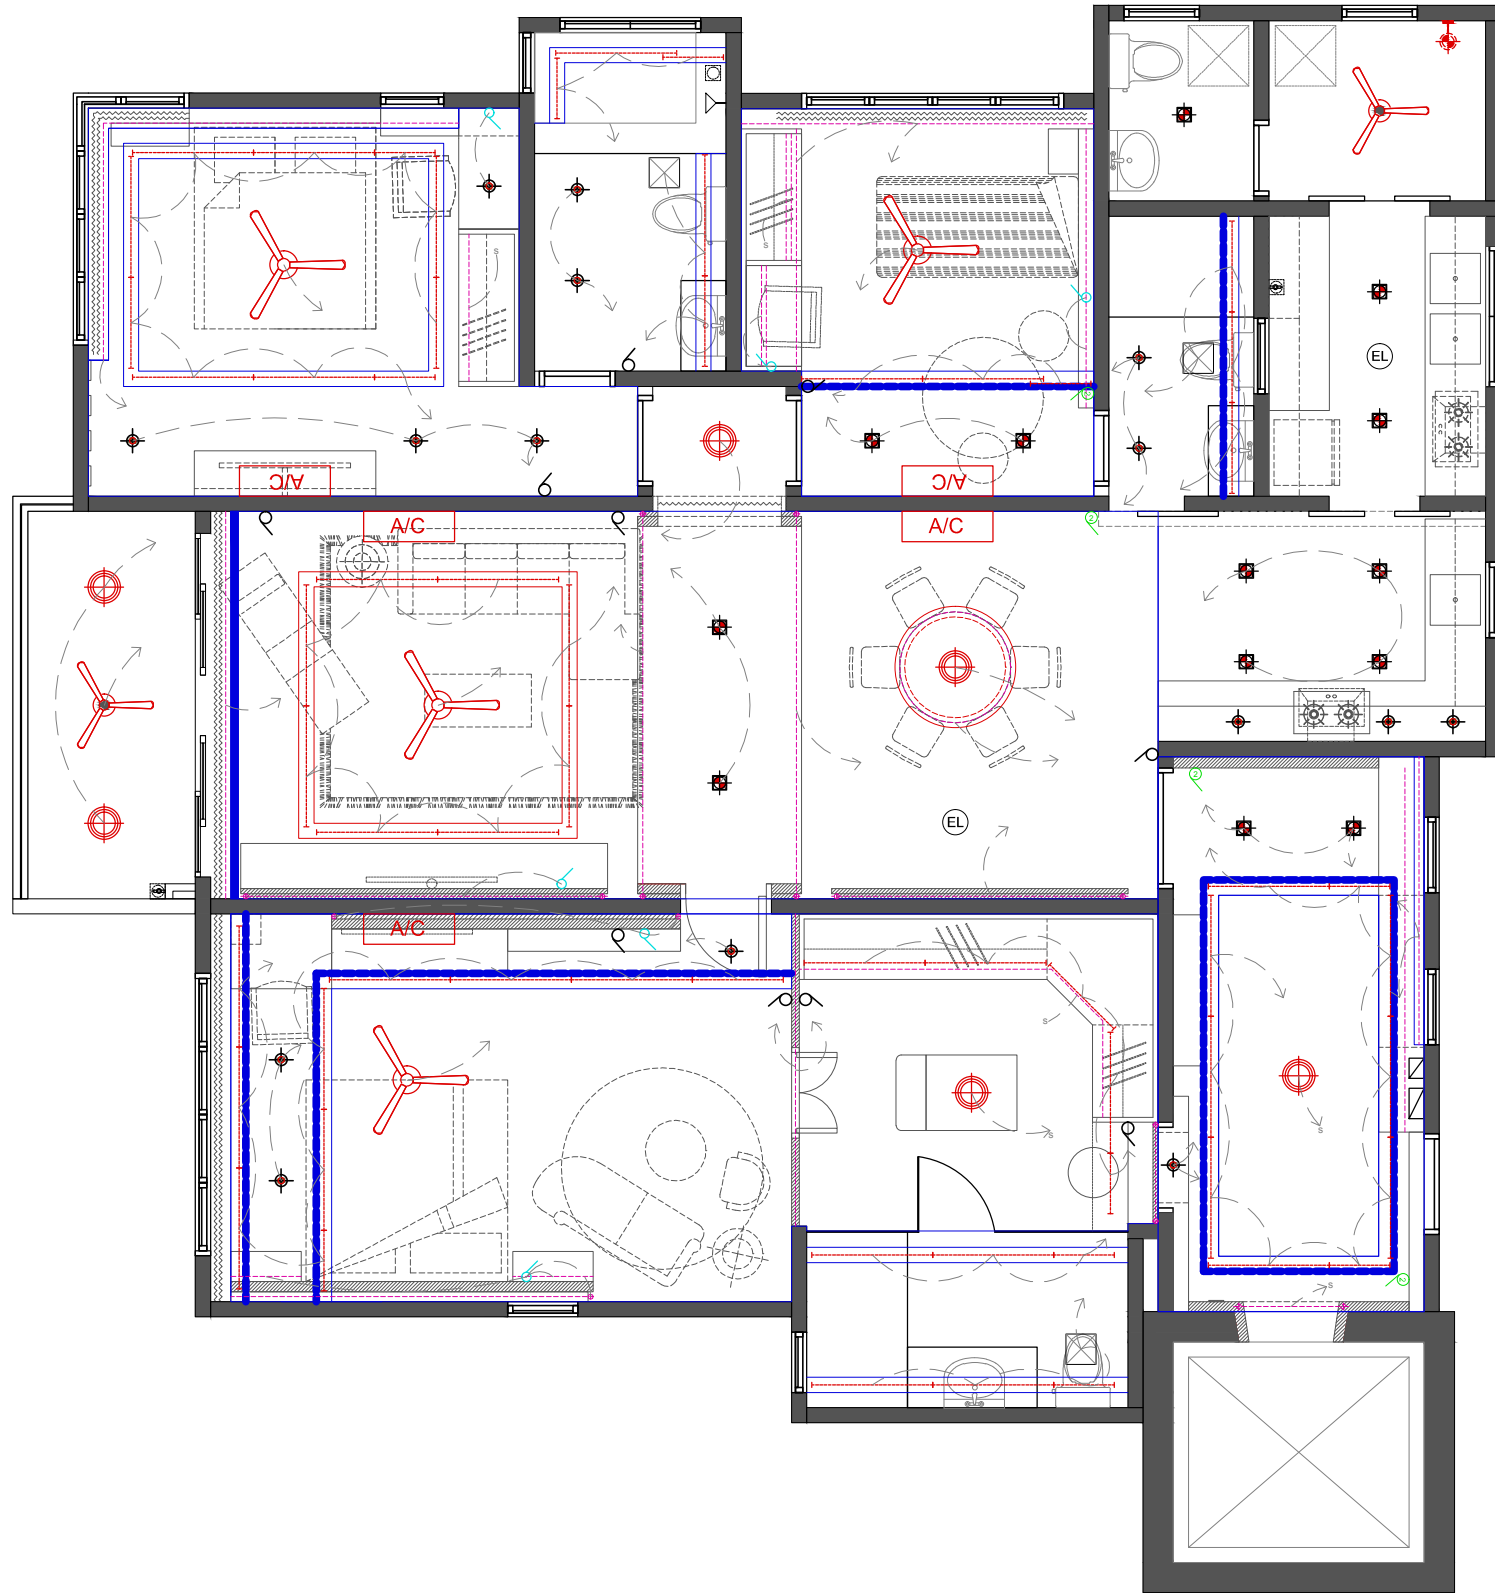

4 LIGHTING PLAN  
Scale 1 : 75

<p>(1213426-P) Remodons Design Sdn Bhd A-G-13A &amp; A-1-13A, Eve Suite Ara Damansara, No.1A, Jalan 1A/ 41, Ara Damansara, 47301 Petaling Jaya, Selangor Darul Ehsan. Tel: 03 - 7610 3855 / 019 - 653 9314 Fax: 03 - 7610 3866 E-mail: enquiry@re-mo-dons-design.com.my Website : www.re-mo-dons-design.com.my</p>	DRAWING TITLE : LIGHTING PLAN	CLIENT : MR LAU	DRAWING NO : LP/WD.104			
		PROJECT : ANJALI NORTH KIARA @ D-21-02	SCALE : AS SHOWN	DATE : 08.06.2018	DRAWN BY : REMONCES	DRAWING STATUS : PRELIMINARY
			JOB NO :	REVISION :	CHECKED :	SHEET NO :