


LIGHTING LEGEND

SYMBOL	DESCRIPTION	QTY	SYMBOL	DESCRIPTION	QTY	SYMBOL	DESCRIPTION
	selected 6" recessed ceiling mounted PLC downlight (square)	13		selected designer pendent light	6		existing aircon provided by developer
	selected 3" recessed LED eye ball	11		selected 4ft 3 fin designer fan	4		
	selected 1200mm (L) LED T5 light tube (WARM WHITE)	44		selected 3ft 3 fin designer baby fan	2		
	selected 900mm (L) LED T5 light tube (WARM WHITE)	8		new emergency light (down light type)	2		
	selected 300mm (L) LED T5 light tube (WARM WHITE)	10		selected wall light	1		
	selected LED strip (5m x3units, 10m x10units)	13		new 300x300mm exhaust fan	3		

* transformer 10m x 9 units, 5m x 11 units

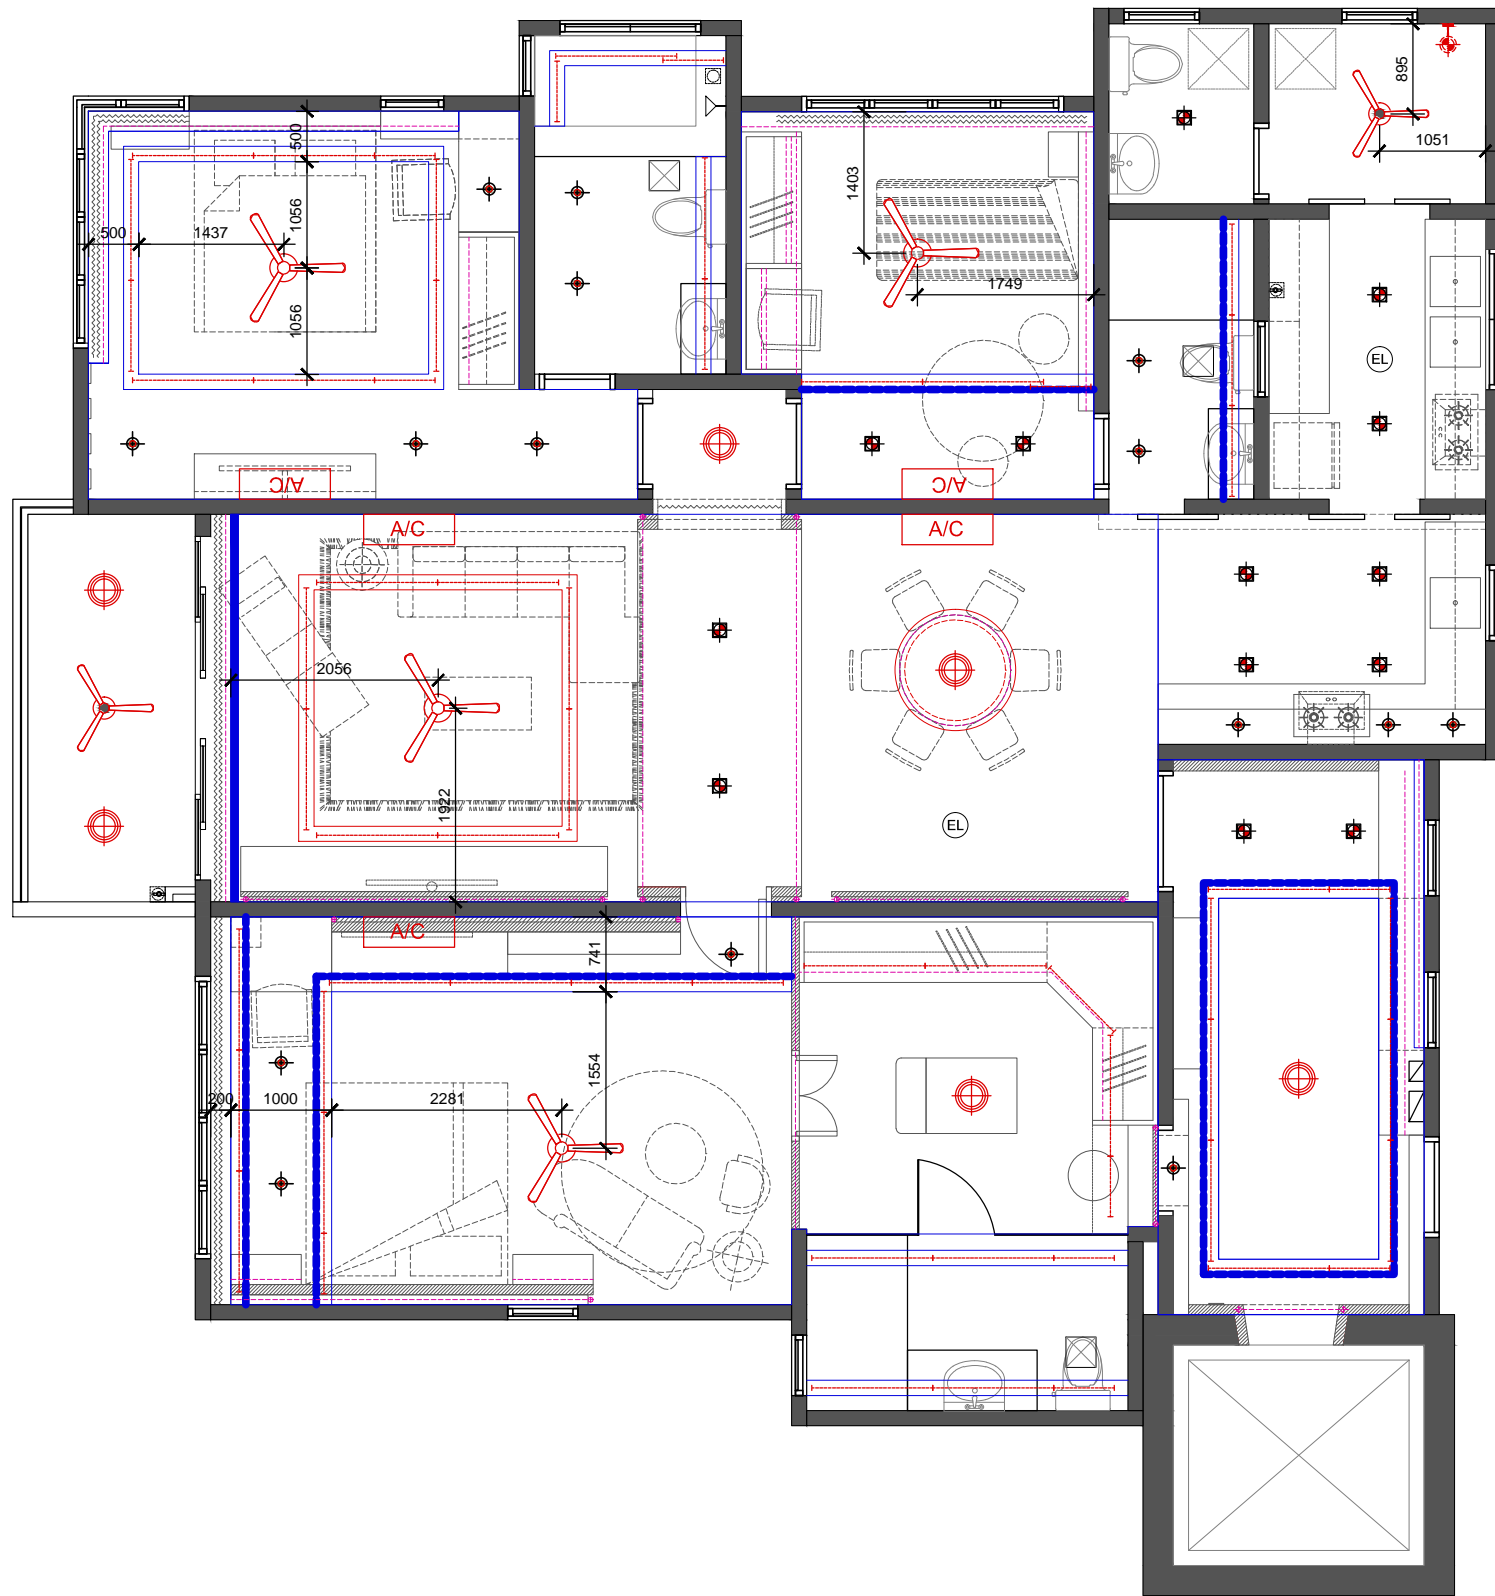

3 REFLECTED CEILING PLAN
Scale 1 : 75

<p>(1213426-P) Remodons Design Sdn Bhd A-G-13A & A-1-13A, Eve Suite Ara Damansara, No.1A, Jalan 1A/ 41, Ara Damansara, 47301 Petaling Jaya, Selangor Darul Ehsan. Tel: 03 - 7610 3855 / 019 - 653 9314 Fax: 03 - 7610 3866 E-mail: enquiry@re-mo-dons-design.com.my Website: www.re-mo-dons-design.com.my</p>	DRAWING TITLE :	CLIENT :	DRAWING NO :		
	REFLECTED CEILING PLAN	MR LAU	RCP/WD.103		
	PROJECT :	SCALE :	DATE :	DRAWN BY :	DRAWING STATUS :
	ANJALI NORTH KIARA @ D-21-02	AS SHOWN	08.06.2018	REMONCES	PRELIMINARY
		JOB NO :	REVISION :	CHECKED :	SHEET NO :